


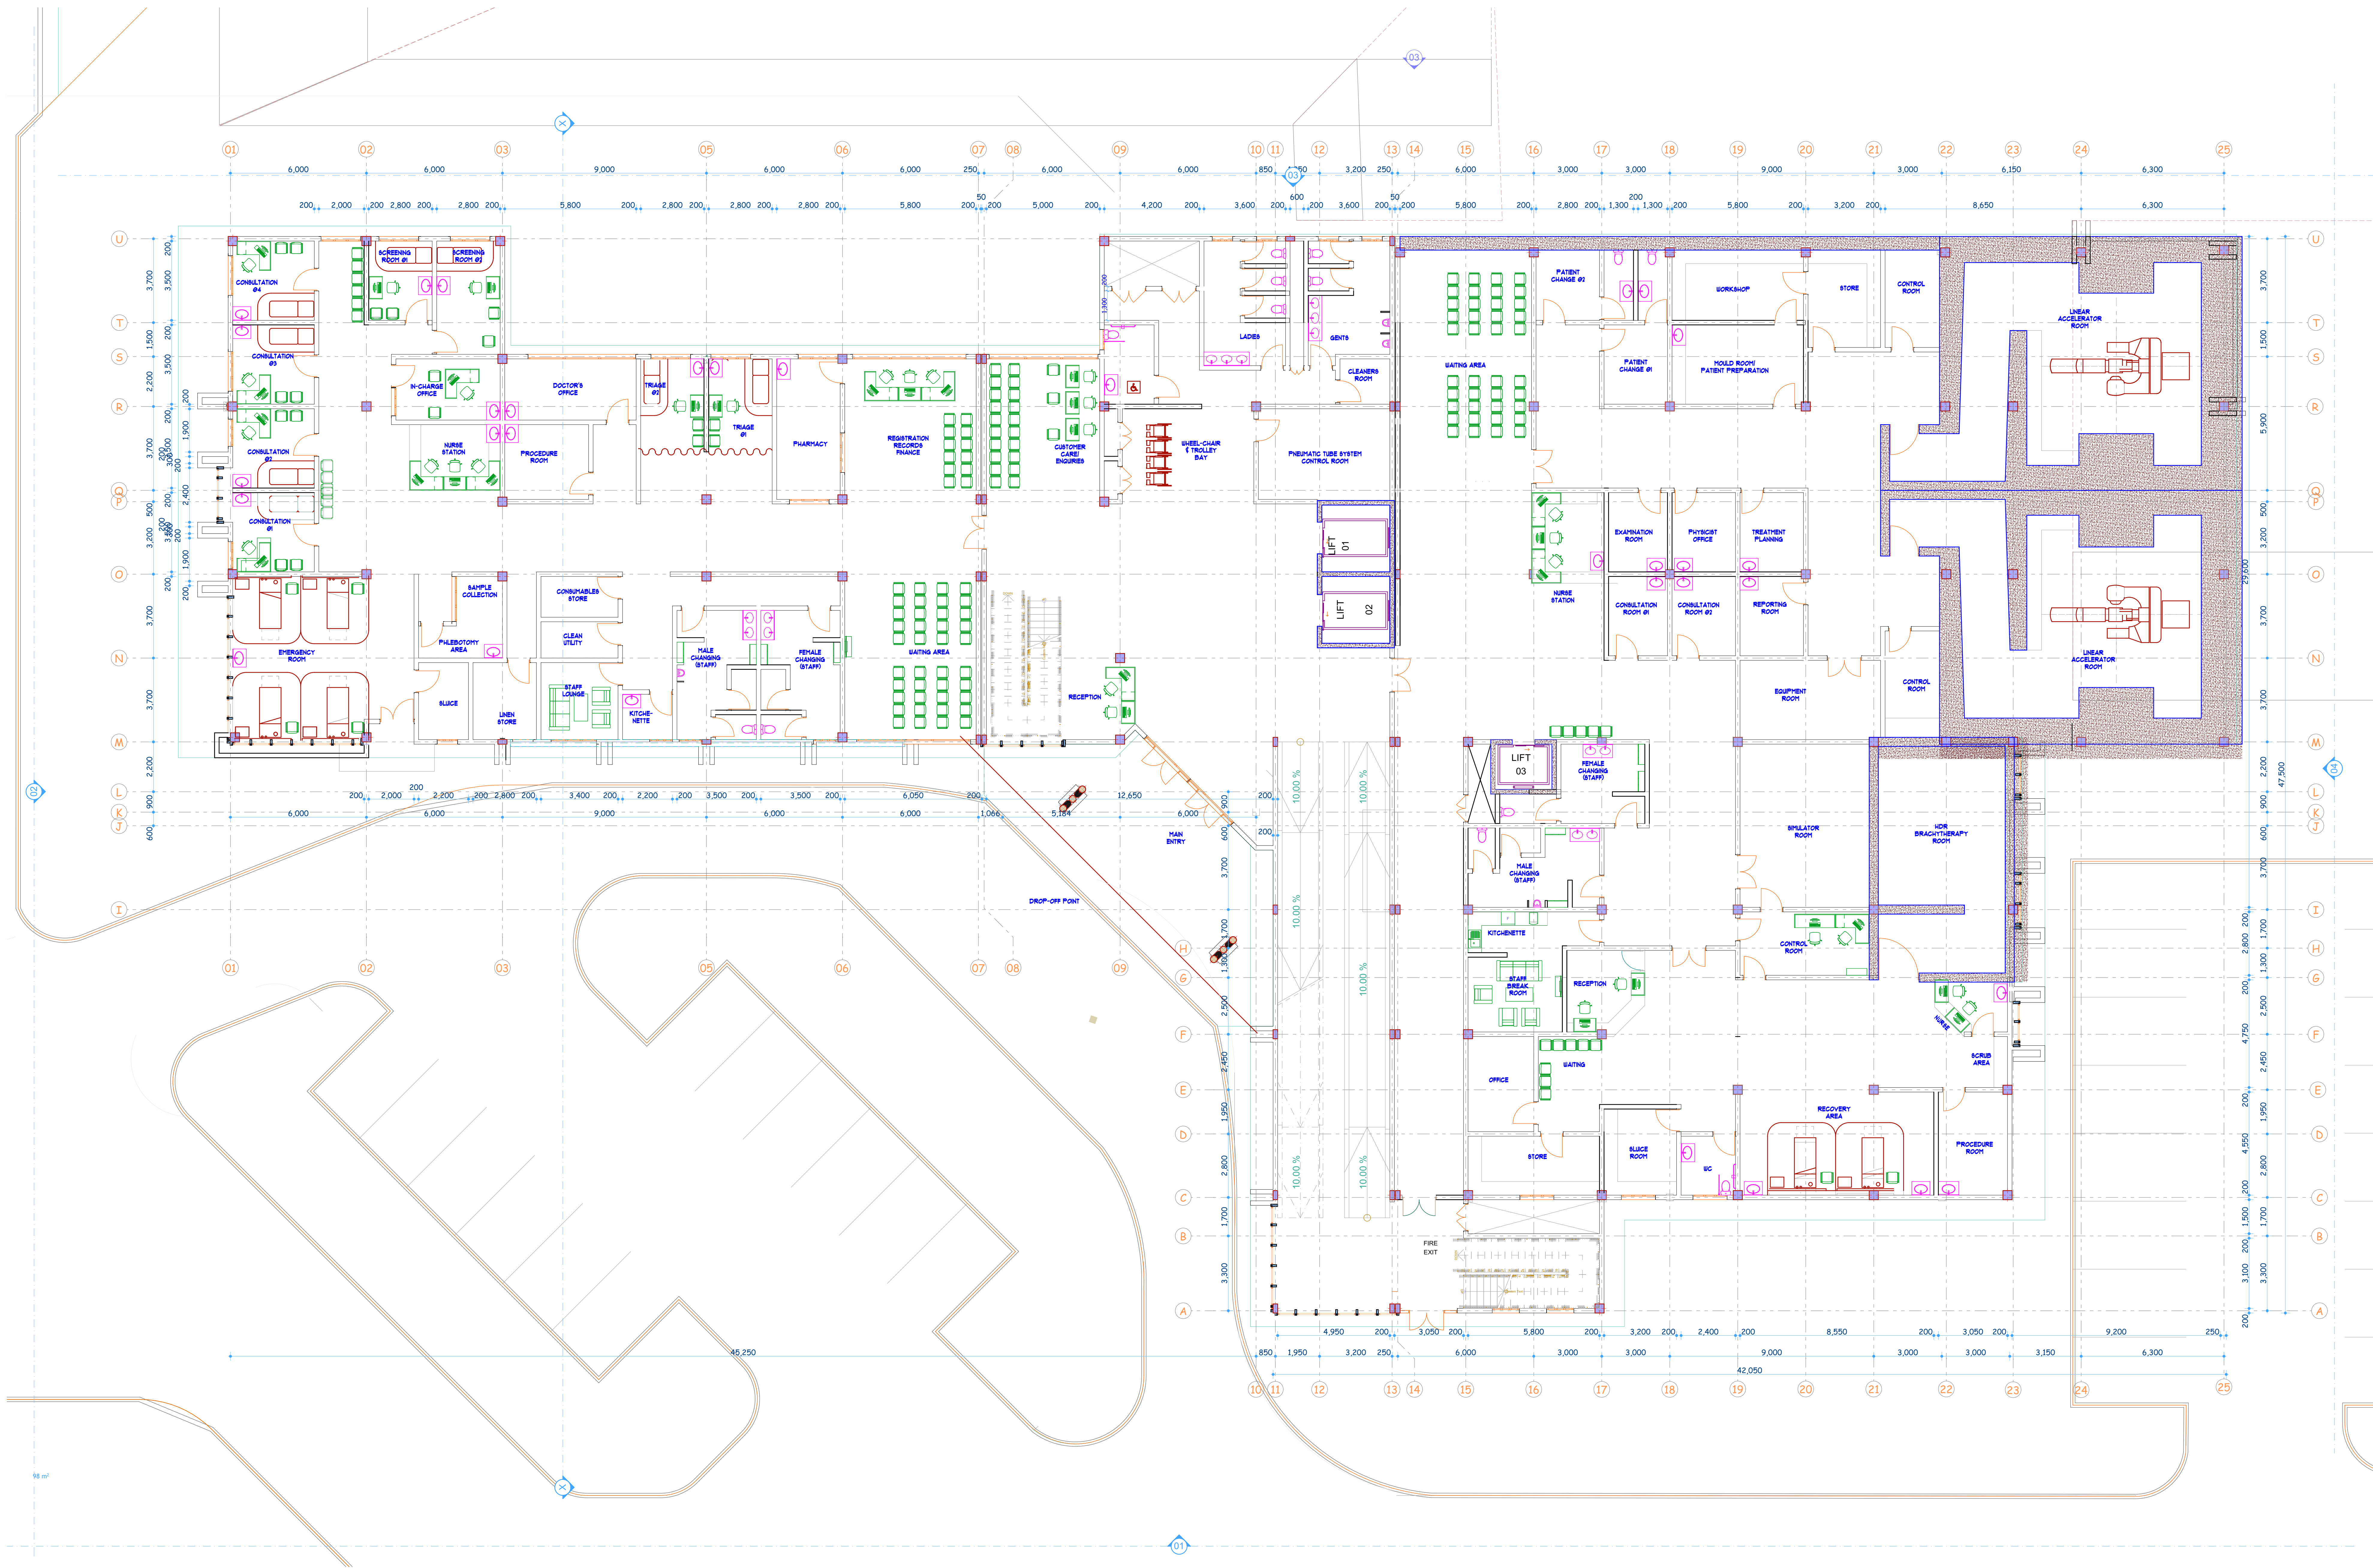

GROUND FLOOR PLAN
1:100

NOTES:

- dimensions should always be read.DO NOT SCALE.
- Contractor to cross check all dimensions and report any discrepancy to the Architect before work is commenced.
- all dimensions are in millimetres unless otherwise stated
- Permanent ventilation (pv) to be provided over all openings except bathroom doors.
- all manhole covers in the drive and parking to be provided with heavy duty and air tight covers.
- all drain pipes under building,parking and driveway to be encased into 150mm thick concrete.
- all rc works to structural engineer's detail.
- Electrical works to be done by a qualified technician and to be done in accordance with KPLCo. regulations
- Mechanical work to MoH and Local Authority's regulations and specifications.
- Water meter to be 300mm minimum above ground level.
- Provide DPC under all walls at ground floor level.
- Provide 1000 gauge polythene DPM under ground floor conc floor slab
- S.V.P. to be provided on all stack pipes.

FIRE NOTES (Applicable in office,ware houses and godowns)

- 1] Provide 4,500 Litres of water with booster pump.
- 2] Provide 30metres long horse reel on each floor
- 3] Provide 1x9 Litres water CO2 Fire Extinguisher at each fire point
- 4] Provide manual/electrical fire alarm system
- 5] Provide emergency lighting with independent power systems

PROJECT:

PROPOSED KISII CANCER CENTRE
IN KENYA

FINANCIERS:

ARAB BANK FOR ECONOMIC DEVELOPMENT IN AFRICA	SAUDI FUND FOR DEVELOPMENT

CLIENT:

REPUBLIC OF KENYA	KISII COUNTY GOVERNMENT

CONSULTANT:

SCHON & ASSOCIATES	NARCO ENGINEERING CONSULTANTS

DRAWING TITLE:

MAIN BUILDING
GROUND FLOOR PLAN

SCALE:		DATE:	
AS SHOWN		NOVEMBER 2020	
DRAWN:	CHECKED:	APPROVED:	
DRAWING NUMBER:			
A-01			
REV:		DATE:	
04		30.11.2020	