


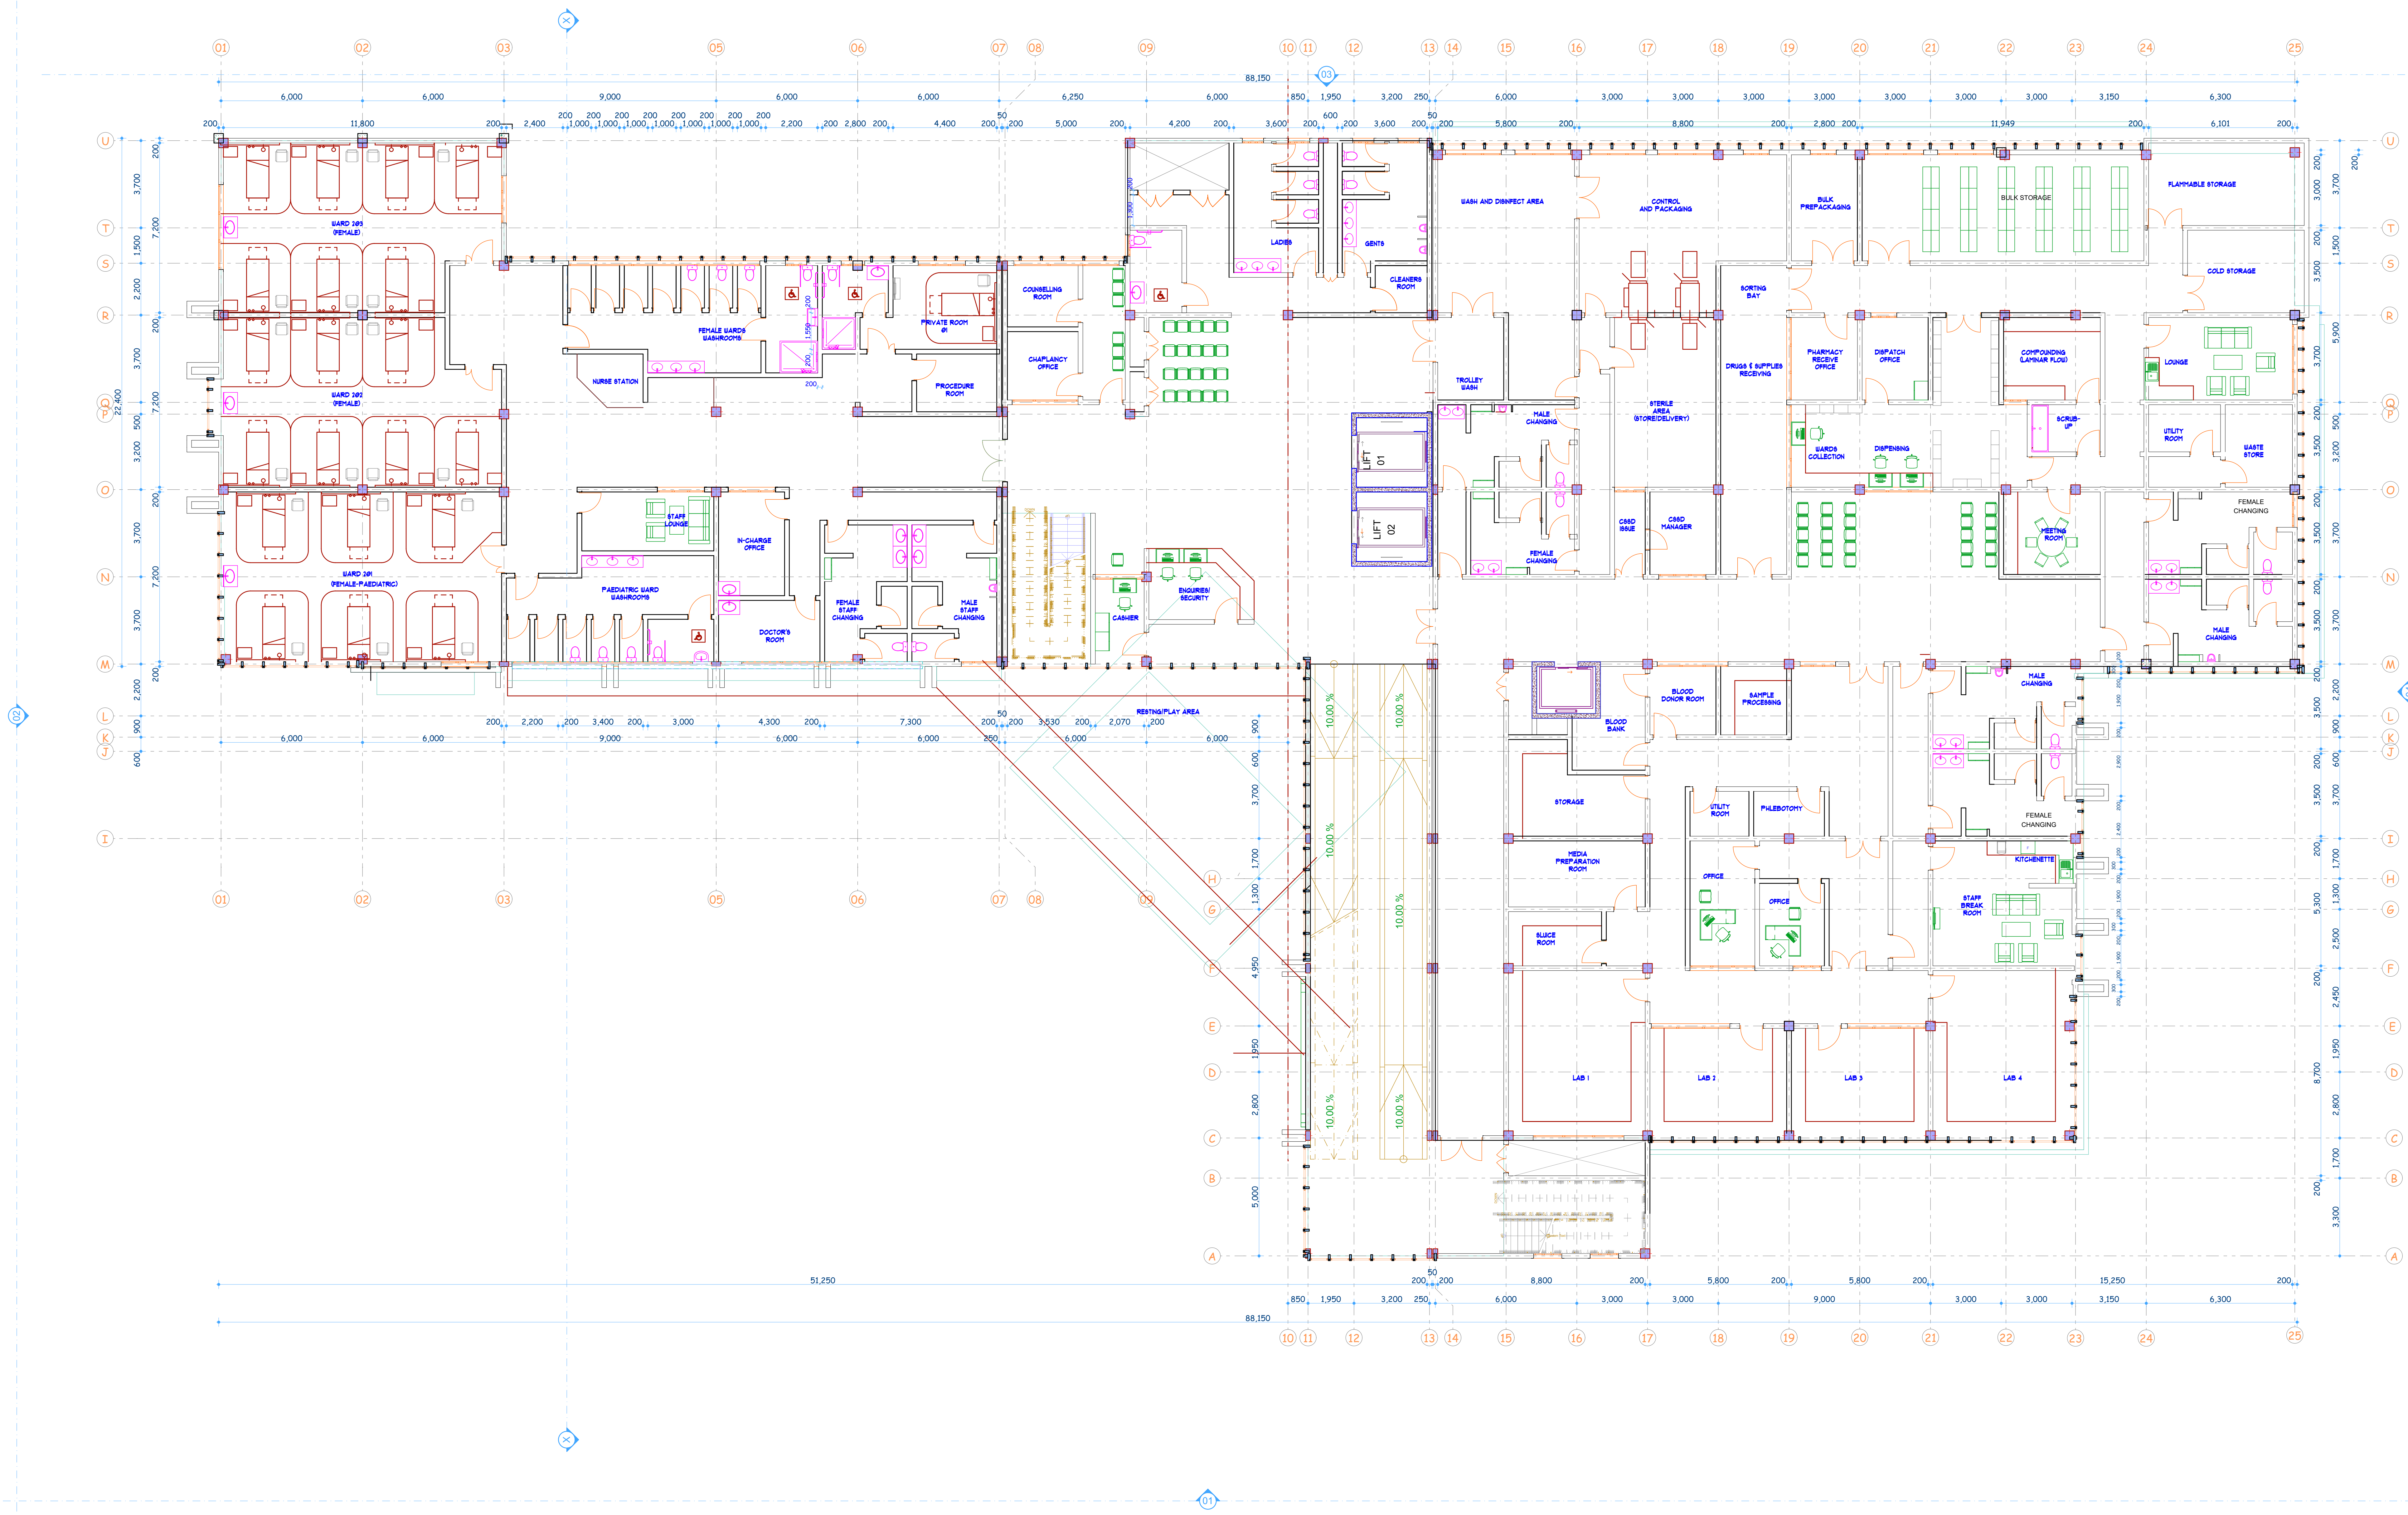

SECOND FLOOR PLAN
1:100

- NOTES:
- dimensions should always be read.DO NOT SCALE.
 - Contractor to cross check all dimensions and report any discrepancy to the Architect before work is commenced.
 - all dimensions are in millimetres unless otherwise stated
 - Permanent ventilation (pv) to be provided over all openings except bathroom doors.
 - all manhole covers in the drive and parking to be provided with heavy duty and air tight covers.
 - all drain pipes under building,parking and driveway to be encased into 150mm thick concrete.
 - all rc works to structural engineer's detail.
 - Electrical works to be done by a qualified technician and to be done in accordance with KPLCo. regulations
 - Mechanical work to MoH and Local Authority's regulations and specifications.
 - Water meter to be 300mm minimum above ground level.
 - Provide DPC under all walls at ground floor level.
 - Provide 1000 gauge polythene DPM under ground floor conc floor slab
 - S.V.P. to be provided on all stack pipes.

- FIRE NOTES (Applicable in office,ware houses and godowns)
- 1] Provide 4,500 Litres of water with booster pump.
 - 2] Provide 30metres long horse reel on each floor
 - 3] Provide 1x9 Litres water CO2 Fire Extinguisher at each fire point
 - 4] Provide manual/electrical fire alarm system
 - 5] Provide emergency lighting with independent power systems

PROJECT:	
PROPOSED KISII CANCER CENTRE IN KENYA	
FINANCIERS:	
ARAB BANK FOR ECONOMIC DEVELOPMENT IN AFRICA	SAUDI FUND FOR DEVELOPMENT
CLIENT:	
REPUBLIC OF KENYA	KISII COUNTY GOVERNMENT
CONSULTANT:	
SCHON & ASSOCIATES	NARCO ENGINEERING CONSULTANTS
DRAWING TITLE:	
MAIN BUILDING SECOND FLOOR PLAN	
SCALE:	DATE:
AS SHOWN	NOVEMBER 2020
DRAWN:	CHECKED: APPROVED:
DRAWING NUMBER:	
A-03	
REV:	DATE:
04	30.11.2020